


Copyright of this drawing is vested in SAGE CONSULTING ENGINEERS Pty. Ltd. and the contents are solely for the use of the client and Project identified on this drawing.

ALL DIMENSIONS ARE IN MILLIMETRES
DRAWN IN ACCORDANCE WITH AS1100-1992
DO NOT SCALE
THIRD ANGLE PROJECTION

0 1m 2m 3m 4m 5m 6m 7m 8m 9m 10m
SCALE 1:100 @ A1

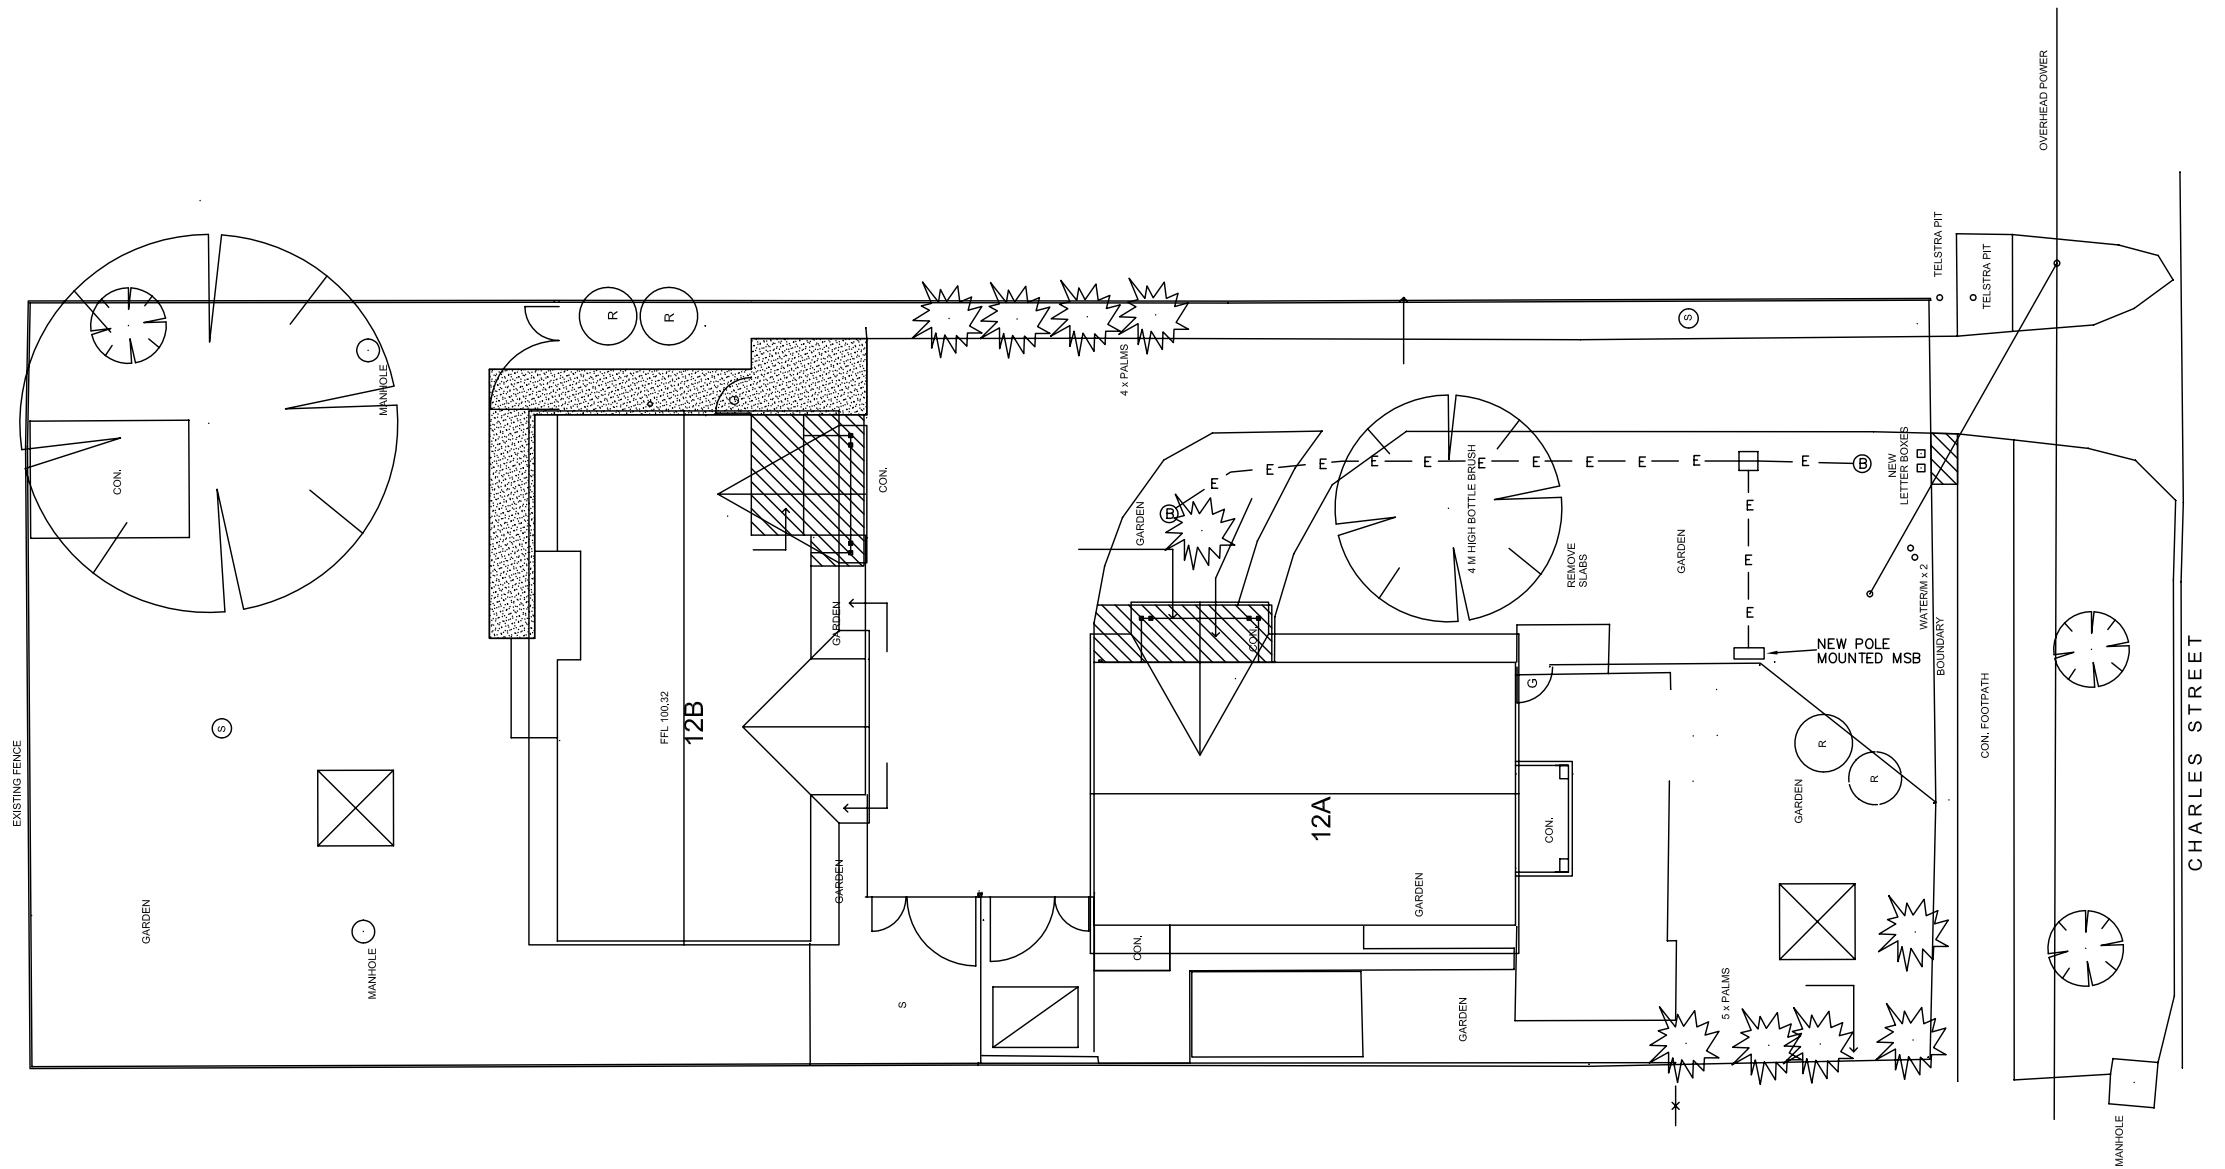

LEGEND:

- ⊙ BOLLARD LIGHT
- E— UNDERGROUND CABLE IN CONDUIT

NOTES:

1. THE LOCATION OF THE BOLLARD LIGHTS ON THIS DRAWING TAKES PRECEDENCE OVER THE LOCATIONS SHOWN ON THE ARCHITECTS DRAWING.

SCOPE OF WORK:

1. COMPLY WITH AS 3000 AND WAER.
2. SUPPLY AND INSTALL BOLLARD LIGHTING INCLUDING CONDUIT BREAKER AND PE SWITCH ON MSB. CABLING IN CONDUIT EXCAVATION AND BACKFILLING, BOLLARD LIGHTS WITH LAMP AND CONCRETE FOOTINGS.
3. REMOVE EXISTING STREETLIGHTS IF REQUIRED AND RELOCATE IT OFFSITE.
4. RELOCATE MAINS CABLING TO COMPLY WITH WAER, IN PARTICULAR PARAGRAPHS 5.4.1 - LOCATION OF MAINS.

ISSUE	REVISION	DATE	CHECKED

SAGE CONSULTING ENGINEERS Pty. Ltd.
 203 RAILWAY ROAD
 SUBIACO W.A. 6008
 TEL: (08) 9388 9745
 FAX: (08) 9388 9256
 Email: msage@inet.net.au
 A.C.N. 082 955 217

MORLEY DAVIS ARCHITECTS
 107 CAMBRIDGE STREET
 LEEDERVILLE W.A.

12 CHARLES STREET

ELECTRICAL SERVICES
 LIGHTING LAYOUT

DESIGNED C.L.	DRAWN M.T.	CHECKED M.D.	CHECKED SAGE
DATE 4/1/2006	SCALE 1:100@A1		

PROJECT No.	DRAWING No.
1543	E1
SHEET 1 OF 1	